


# 범례도

-  : 5G ORU
-  : 5G IRU
-  : FHM
-  : 전원케이블
-  : 광케이블

13 14 여 분

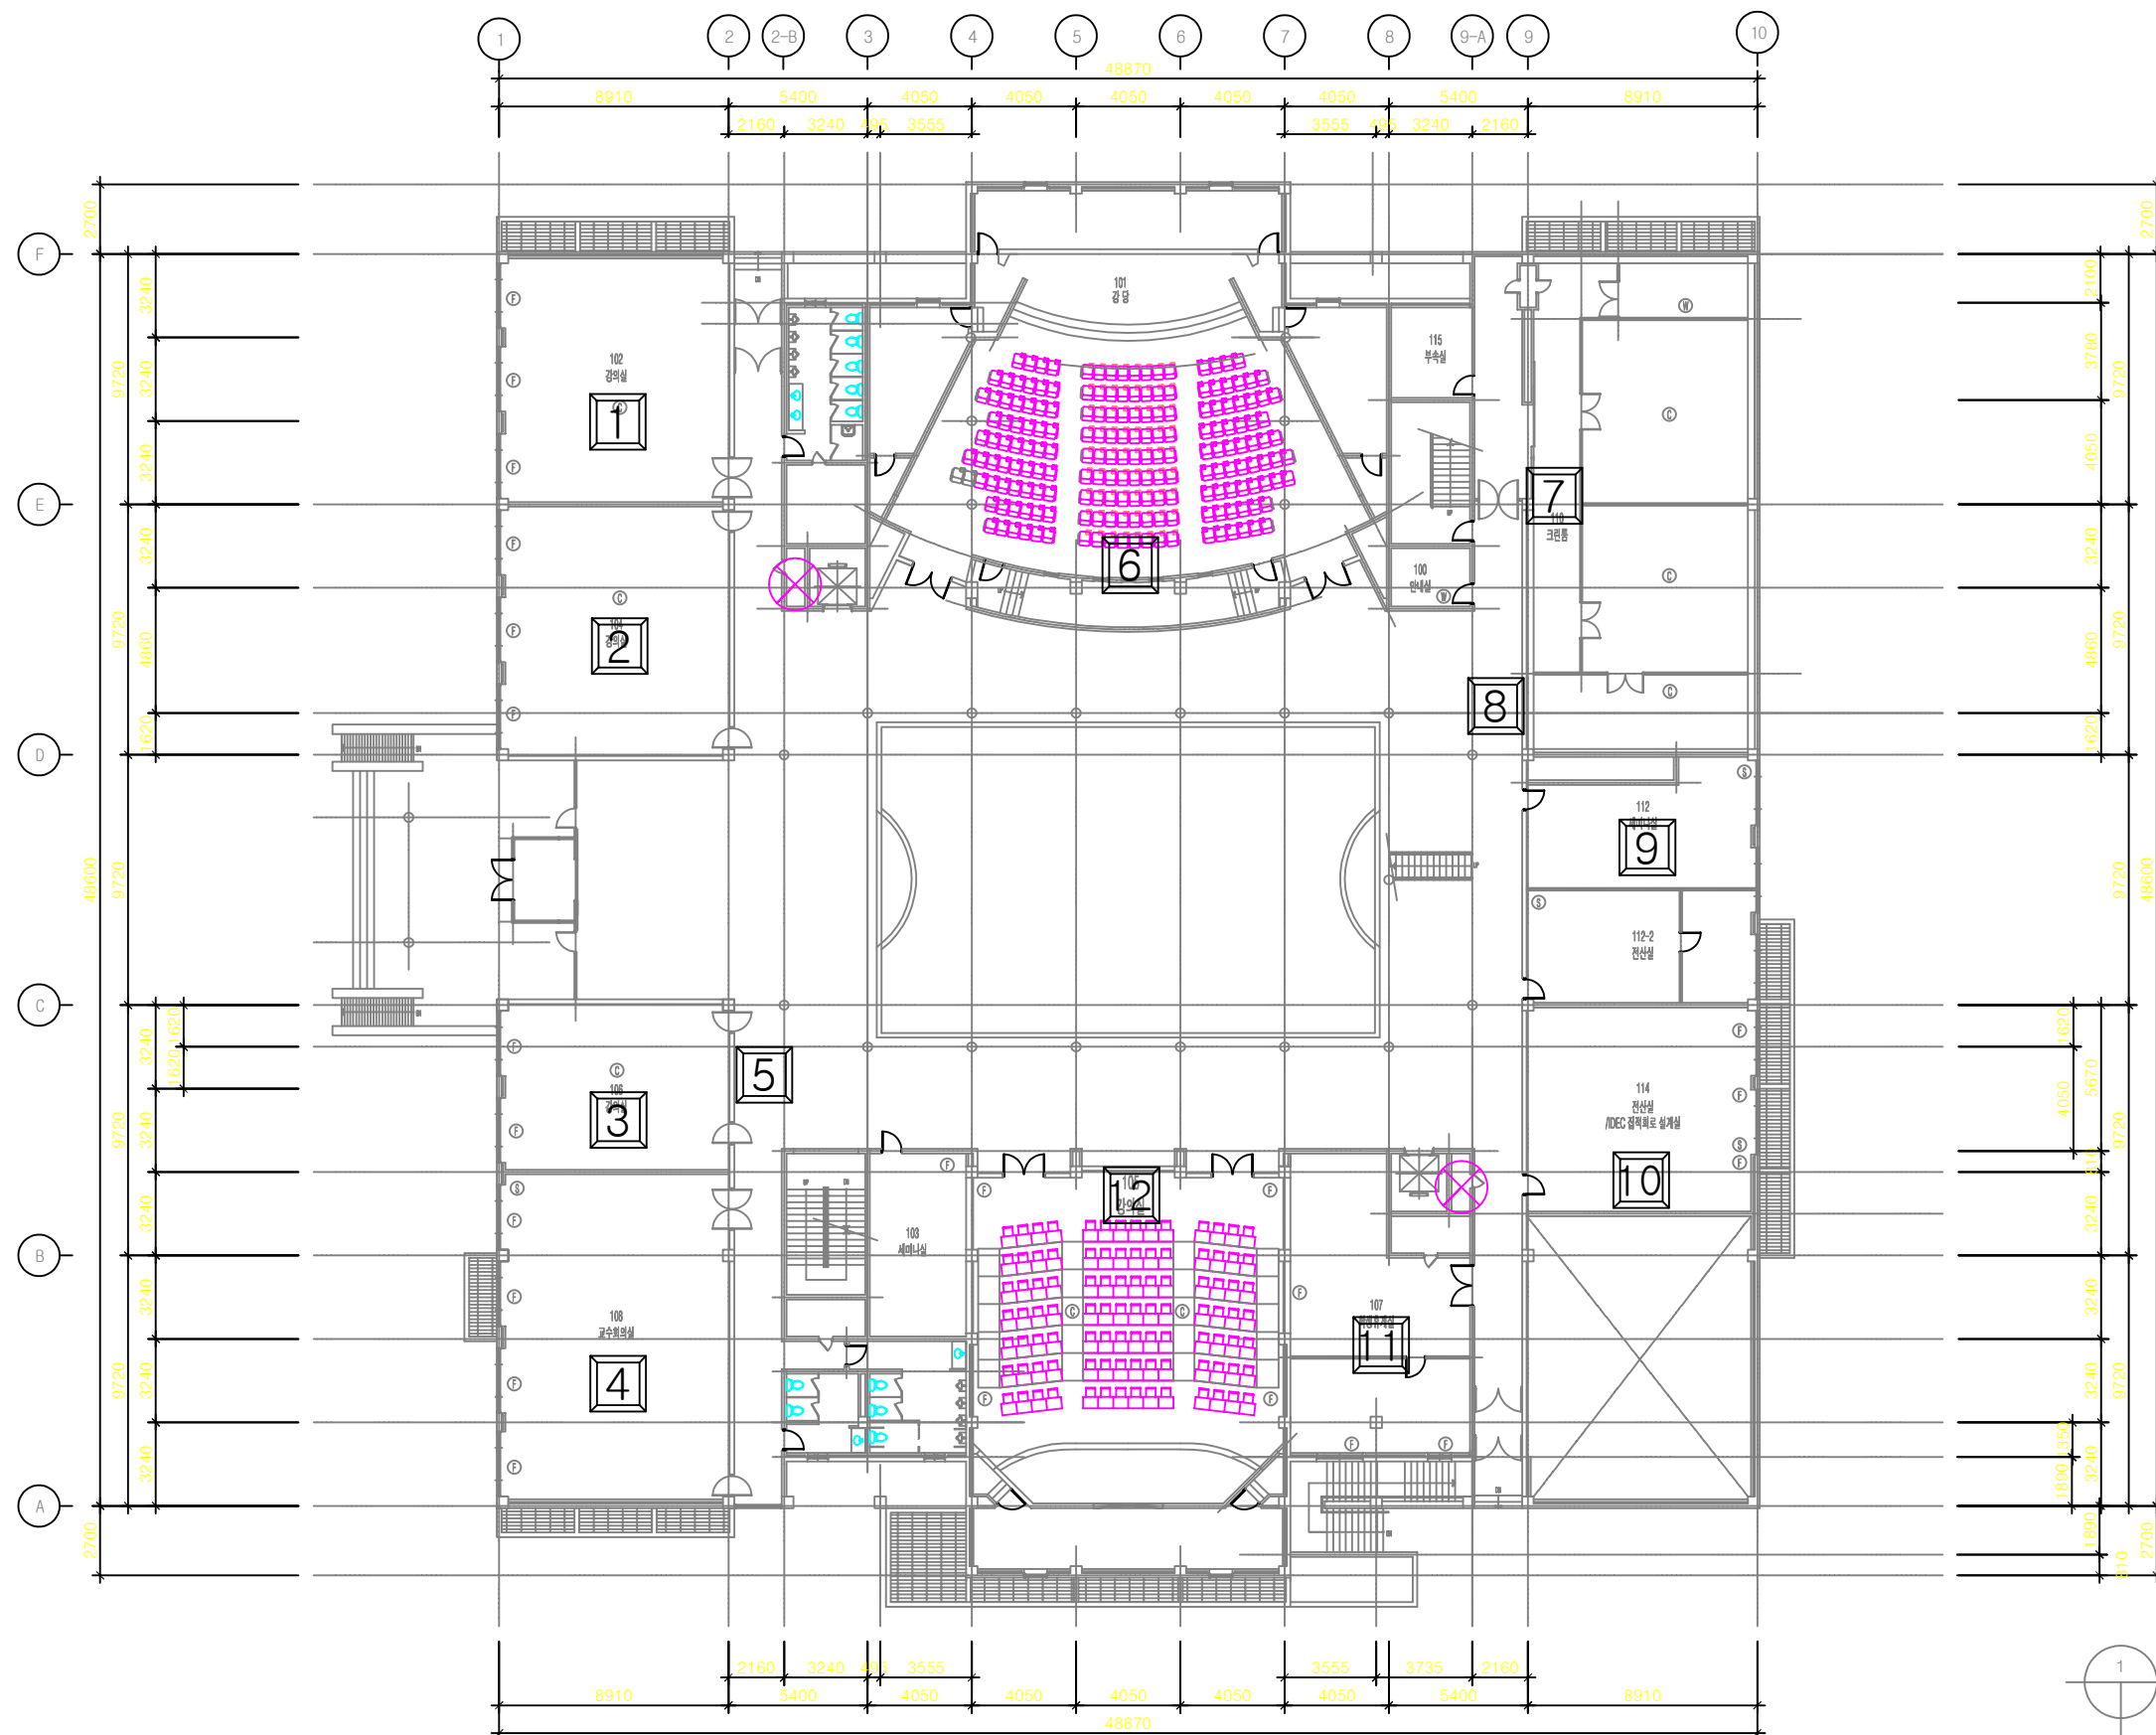

LG전자 연구동  
지상 1층 평면도  
SCALE=1/300

- 범례
-  : F.C.U
  -  : 천정형
  -  : 벽걸이형
  -  : 스탠드형



**POSTECH**  
POHANG UNIVERSITY OF SCIENCE AND TECHNOLOGY

|                      |             |                      |                  |                                              |                                 |
|----------------------|-------------|----------------------|------------------|----------------------------------------------|---------------------------------|
| DRAWN BY<br>OH. D. J | DESIGNED BY | DATE<br>2016. 12. 31 | SCALE<br>1 / 300 | NAME OF DRAWING<br><b>LG전자 연구동 지상 1층 평면도</b> | DRAWING NO.<br><b>P019-A-1F</b> |
| CHECKED BY           | APPROVED BY | CONSULTANTS          |                  |                                              | SHEET NO.                       |

# 범례도


 : 5G ORU

 : 5G IRU

 : FHM

 : 전원케이블

 : 광케이블

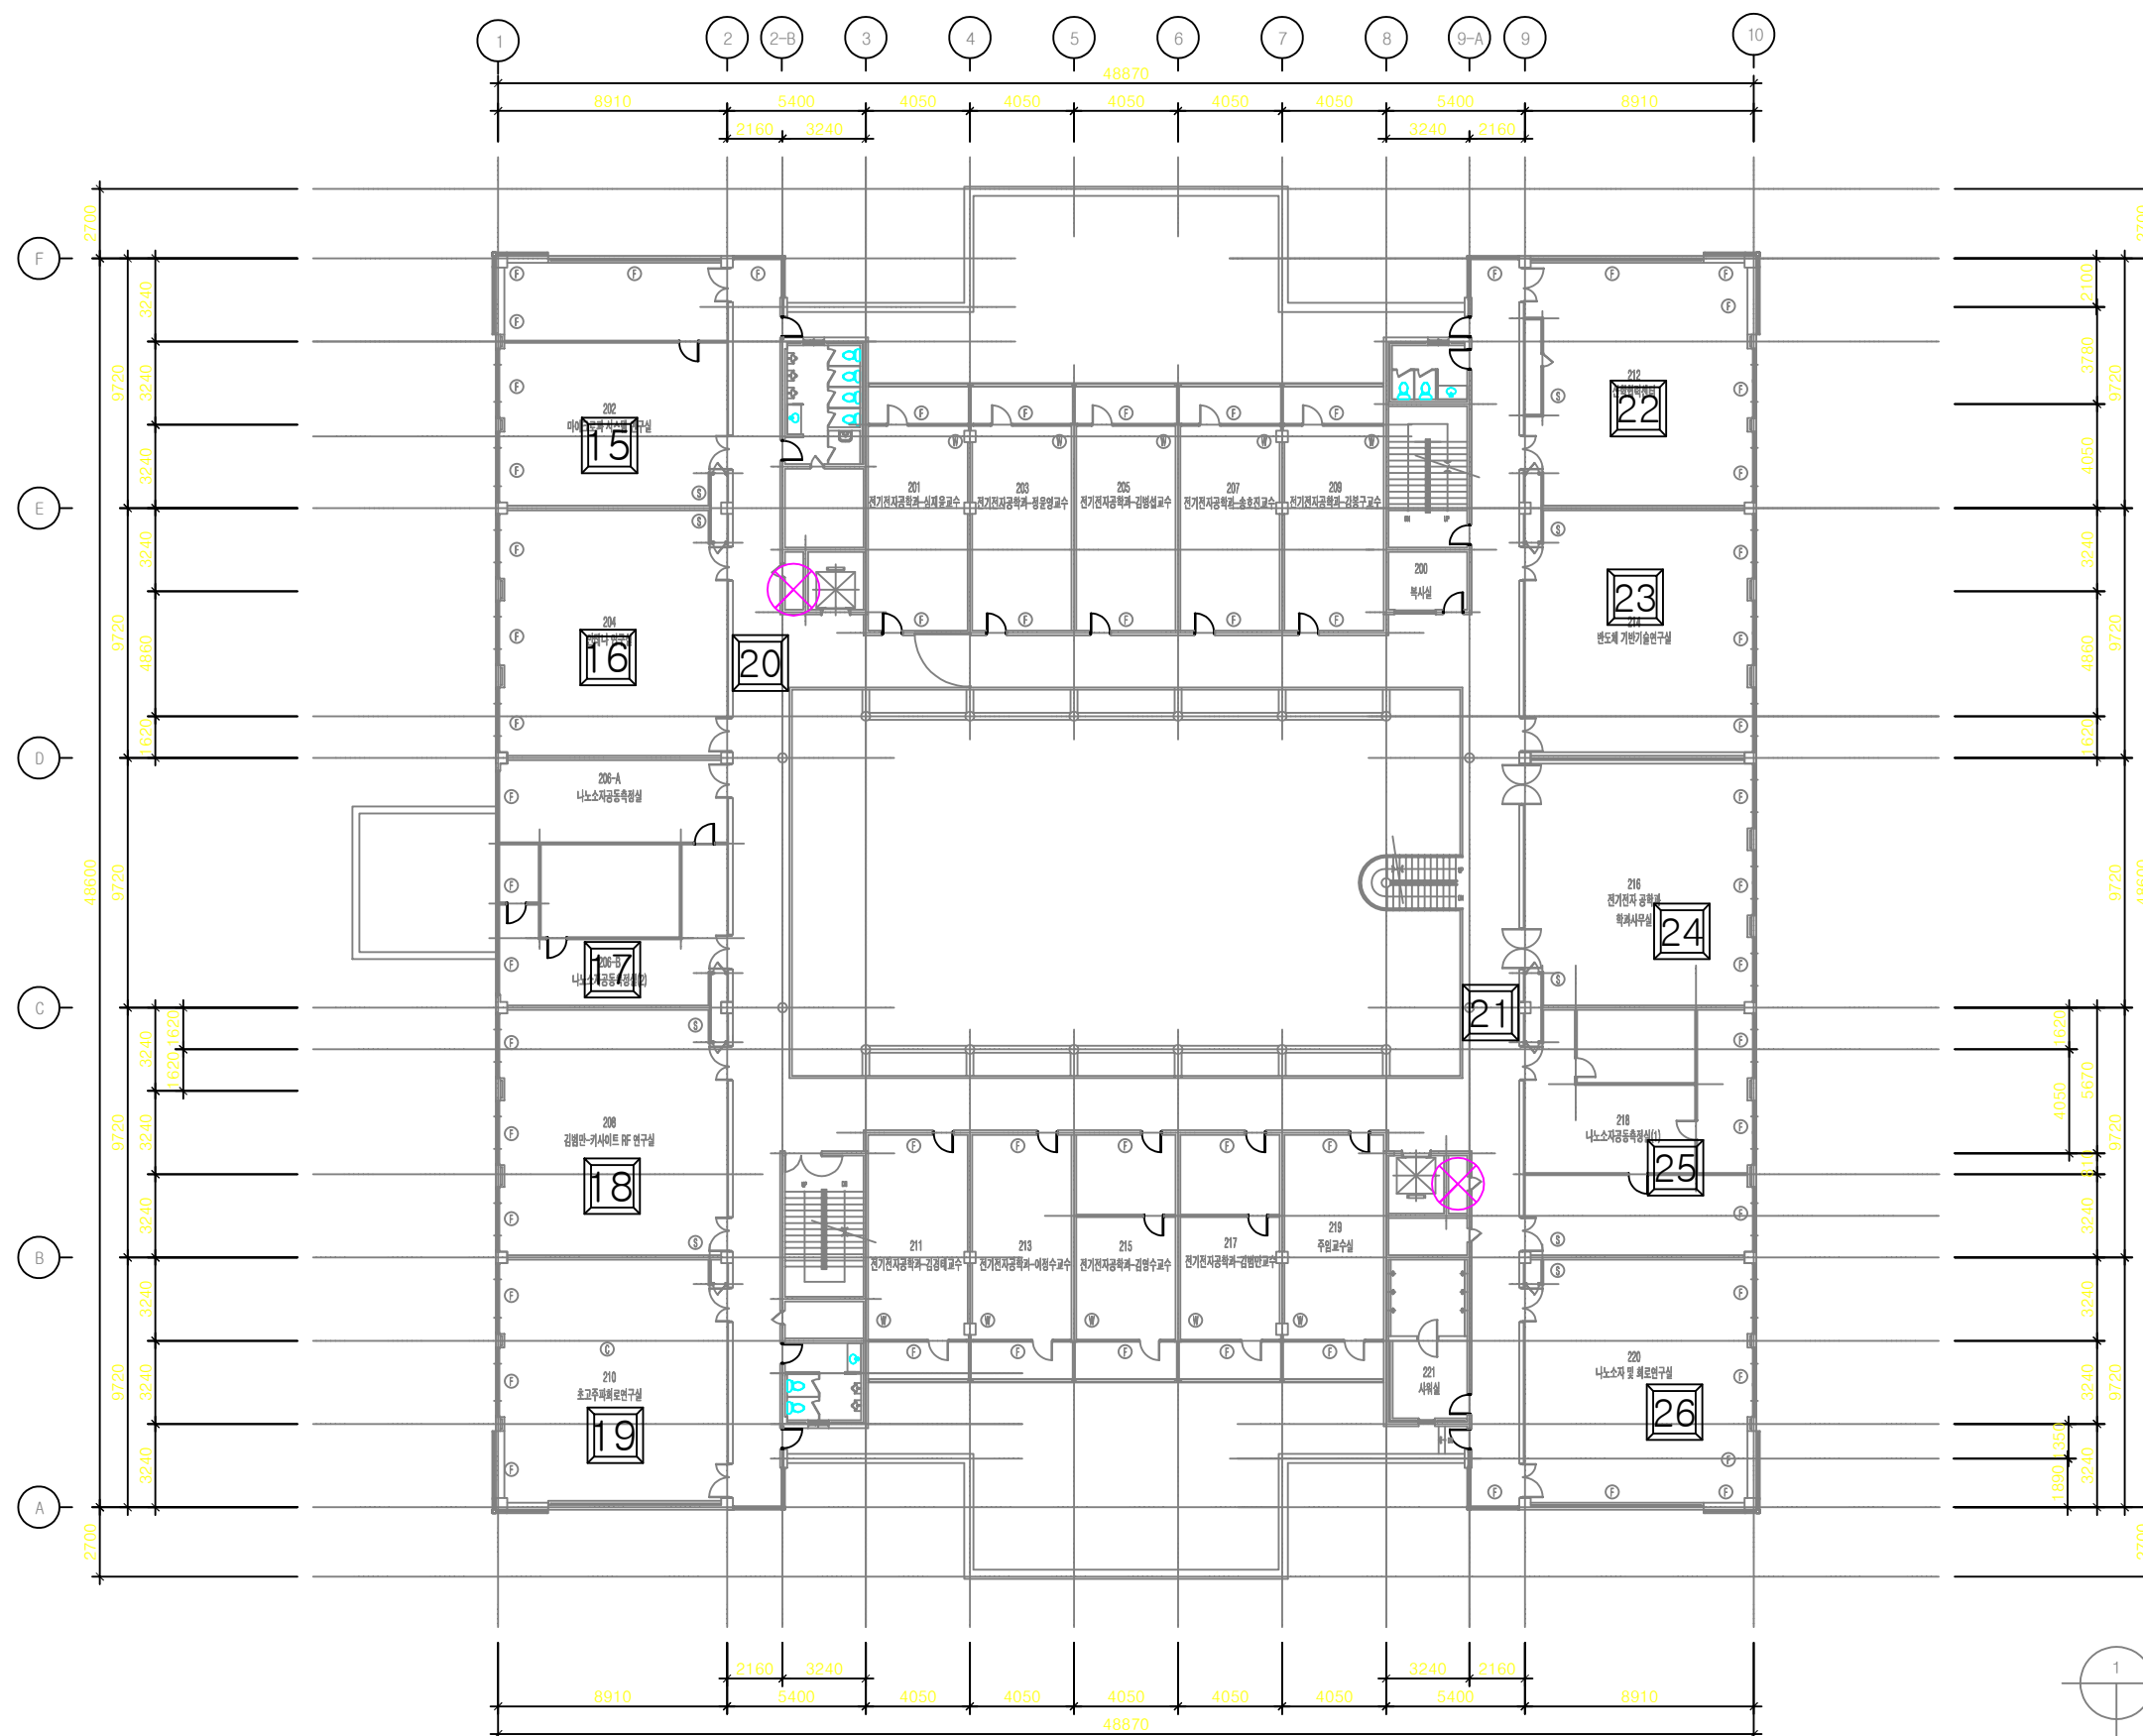

LG전자 연구동  
지상 2층 평면도  
SCALE=1/300

- 범례
- F : F.C.U
  - C : 천정형
  - W : 벽걸이형
  - S : 스탠드형



**POSTECH**  
POHANG UNIVERSITY OF SCIENCE AND TECHNOLOGY

DRAWN BY  
OH. D. J

DESIGNED BY

DATE  
2016. 12. 31

SCALE  
1 / 300

NAME OF DRAWING

LG전자 연구동 지상 2층 평면도

DRAWING NO.  
P019-A-2F

SHEET NO.


CHECKED BY

APPROVED BY

CONSULTANTS

# 범례도

-  : 5G ORU
-  : 5G IRU
-  : FHM
-  : 전원케이블
-  : 광케이블

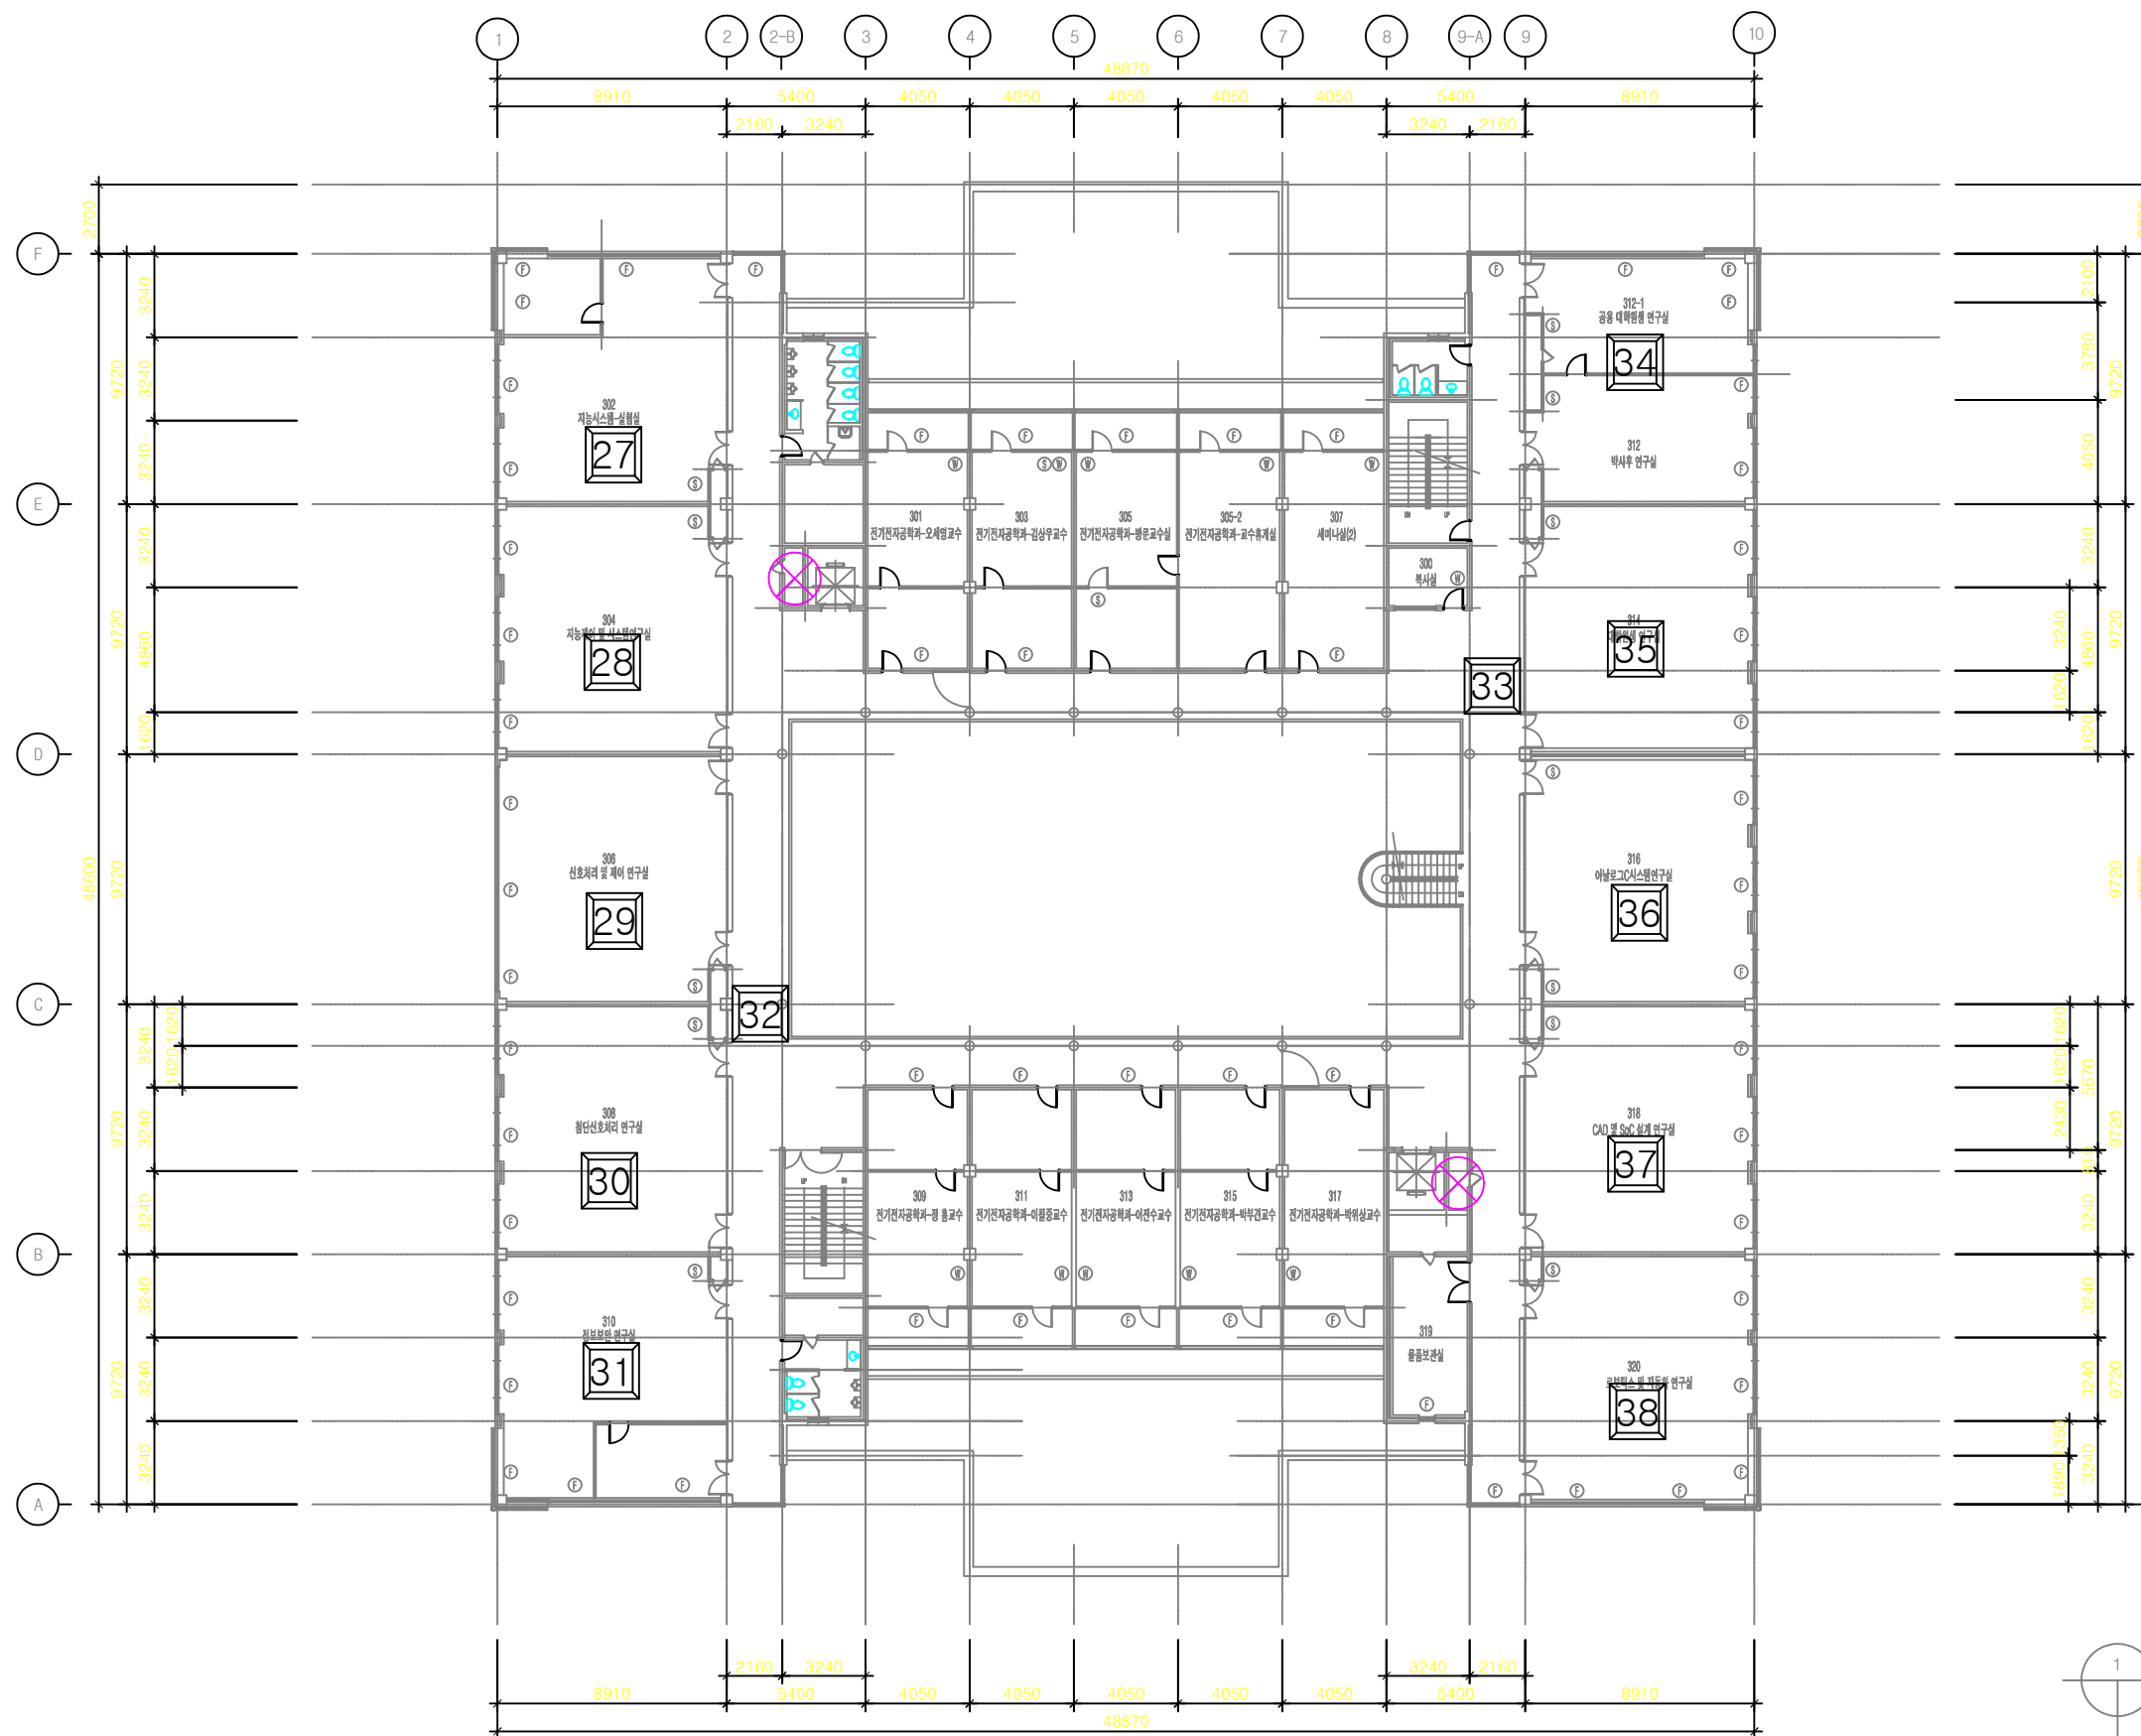

LG전자 연구동  
지상 3층 평면도  
SCALE=1/300

범례


-  : F.C.U
-  : 천정형
-  : 벽걸이형
-  : 스탠드형



**POSTECH**  
POHANG UNIVERSITY OF SCIENCE AND TECHNOLOGY

|                      |             |                      |                  |                                              |                                 |
|----------------------|-------------|----------------------|------------------|----------------------------------------------|---------------------------------|
| DRAWN BY<br>OH. D. J | DESIGNED BY | DATE<br>2016. 12. 31 | SCALE<br>1 / 300 | NAME OF DRAWING<br><b>LG전자 연구동 지상 3층 평면도</b> | DRAWING NO.<br><b>P019-A-3F</b> |
| CHECKED BY           | APPROVED BY | CONSULTANTS          |                  |                                              | SHEET NO.                       |

 : 5G ORU  
 : 5G IRU  
 : FHM  
 : 전원케이블  
 : 광케이블

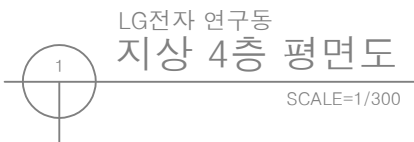

**POSTECH**  
POHANG UNIVERSITY OF SCIENCE AND TECHNOLOGY

SHEET NO.